


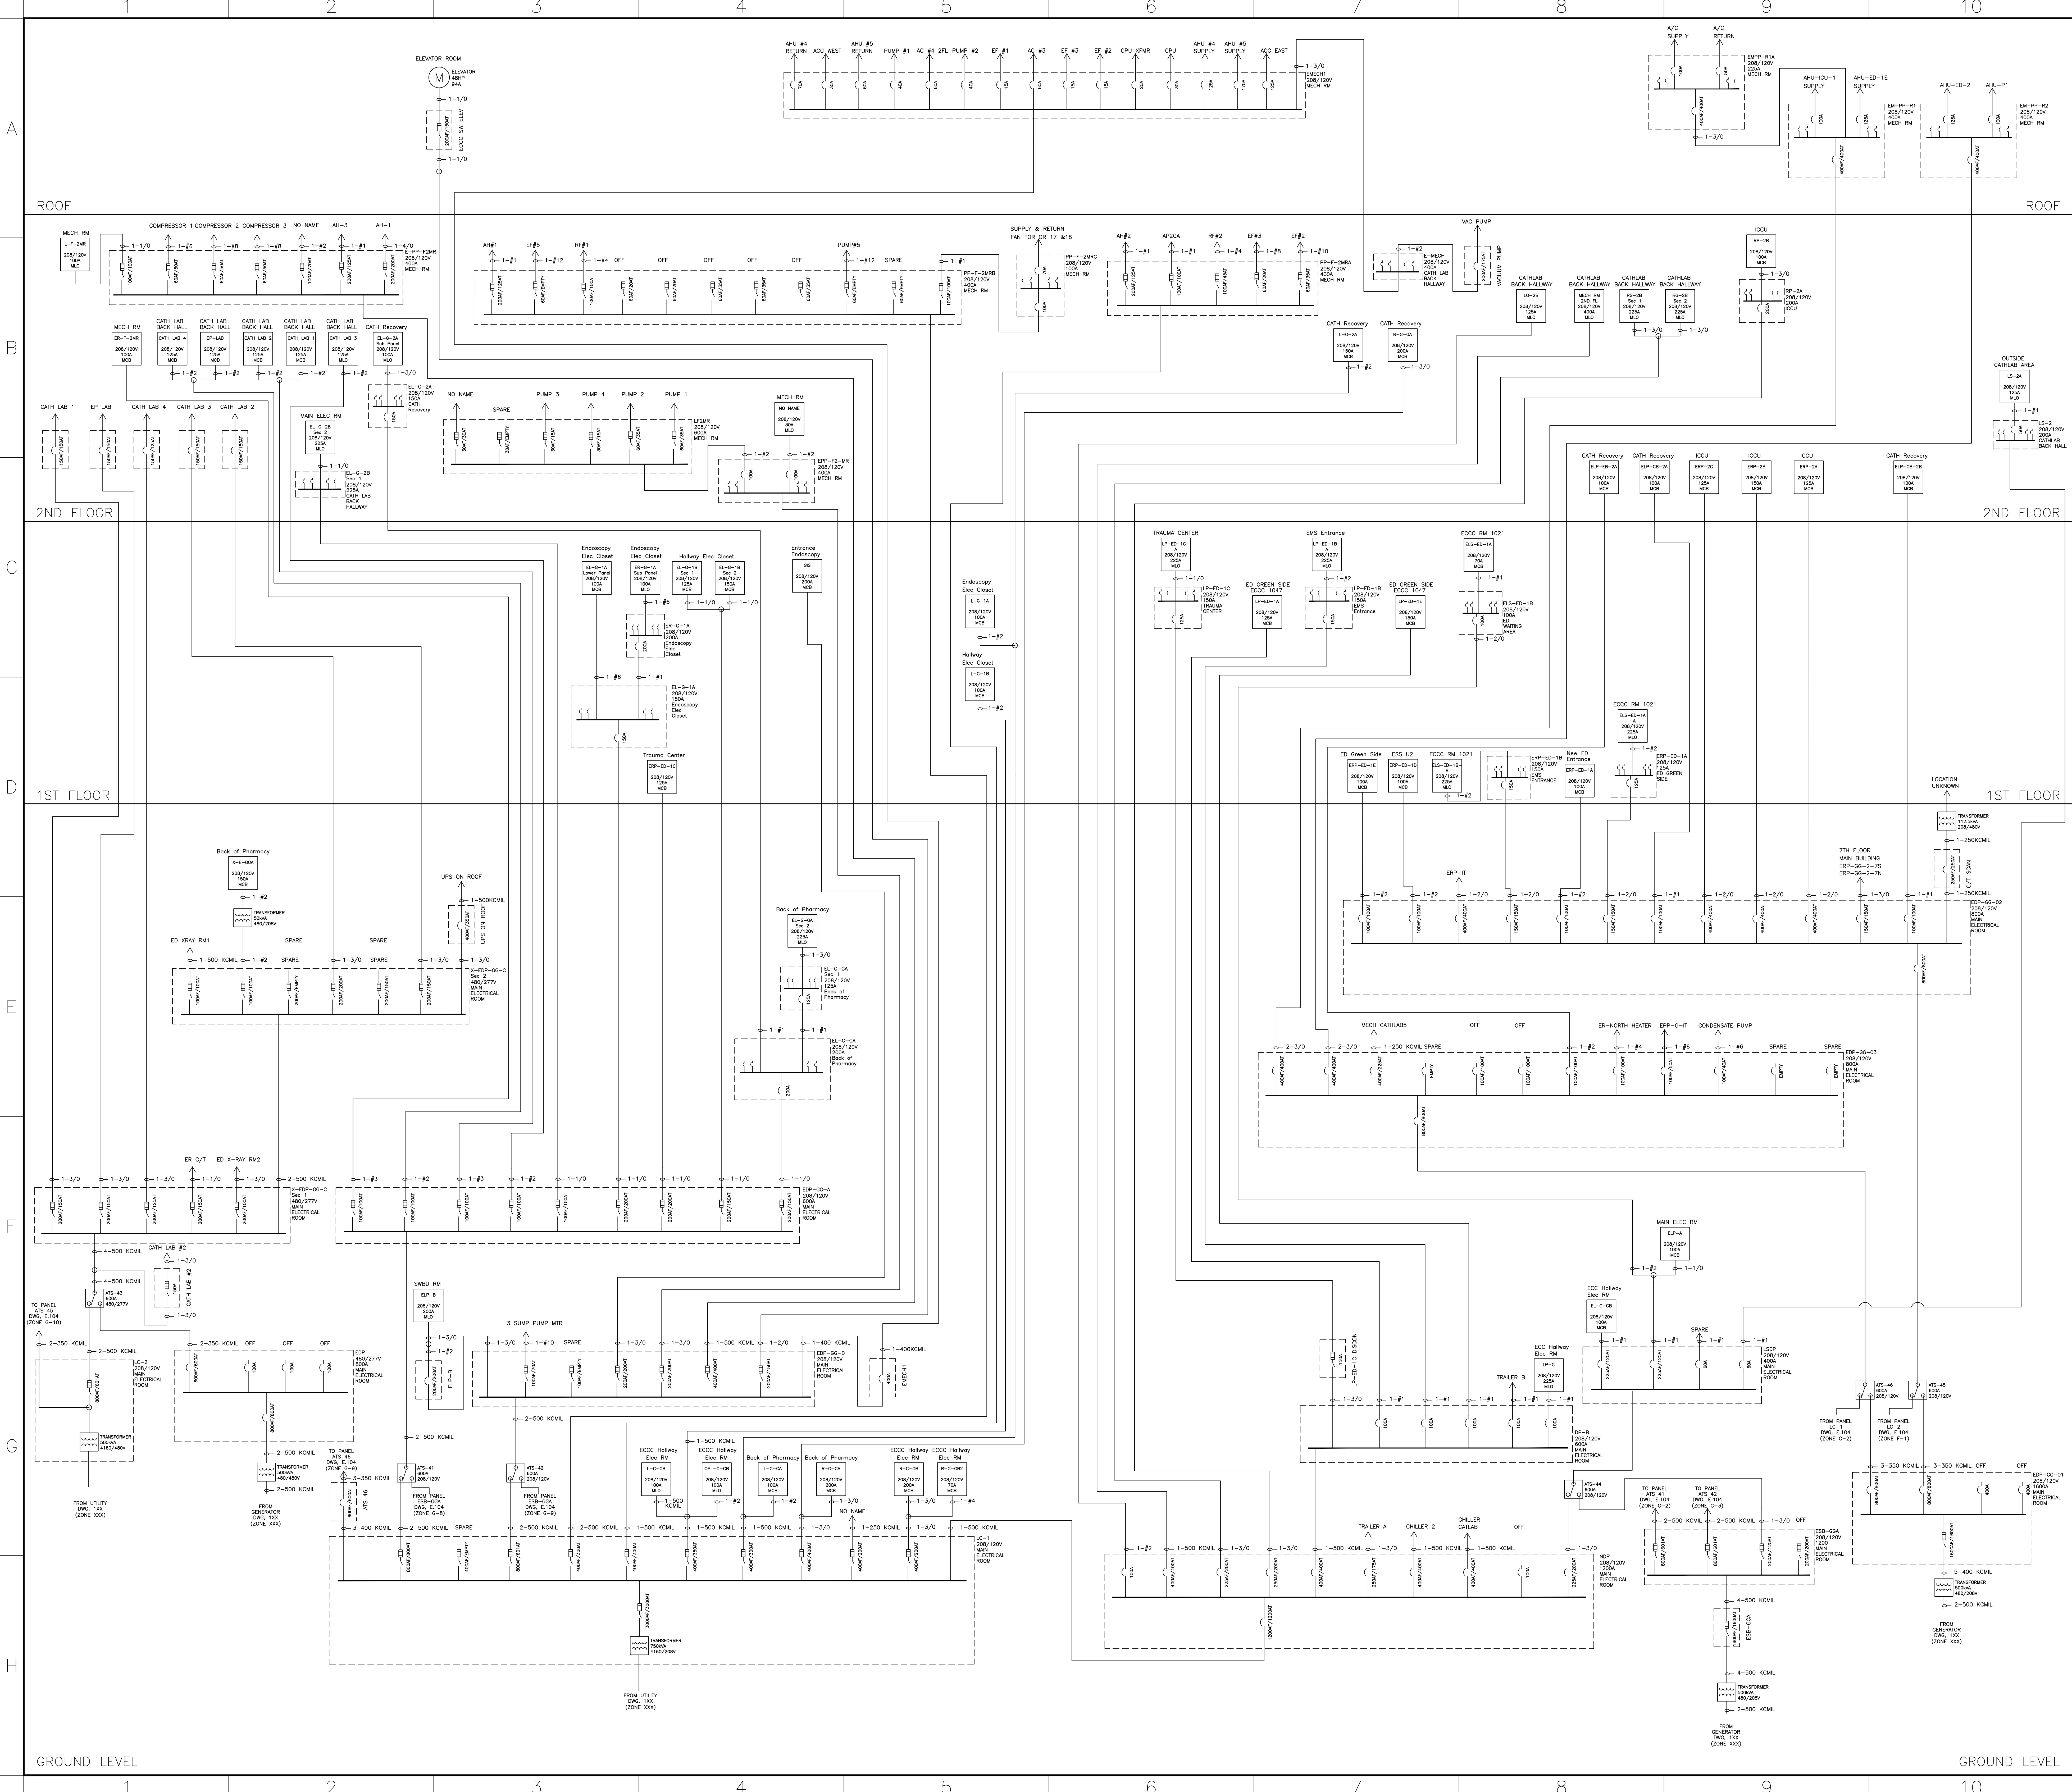

NOTES:
1. DRAWING NOT TO SCALE

REV.	DATE	BY	DESCRIPTION
 220 MAPLE AVE ROCKVILLE CENTRE NY 11570 LONG ISLAND JEWISH MEDICAL CENTER 270-05 76TH AVE, NEW HYDE PARK, NY 11040 SINGLE LINE DIAGRAM MC ED & OVERBUILD ICU BEDS (ECC BUILDING)			
DATE	DRAWN BY	SCALE	DRAWING NUMBER
07/29/15	HS	NONE	E.104